


4 nos. 230 DIA WALL MOUNTED PROPELLER TYPE EXHAUST FAN OPENING IN WALL FOR 250 MM DIA EXH. FAN

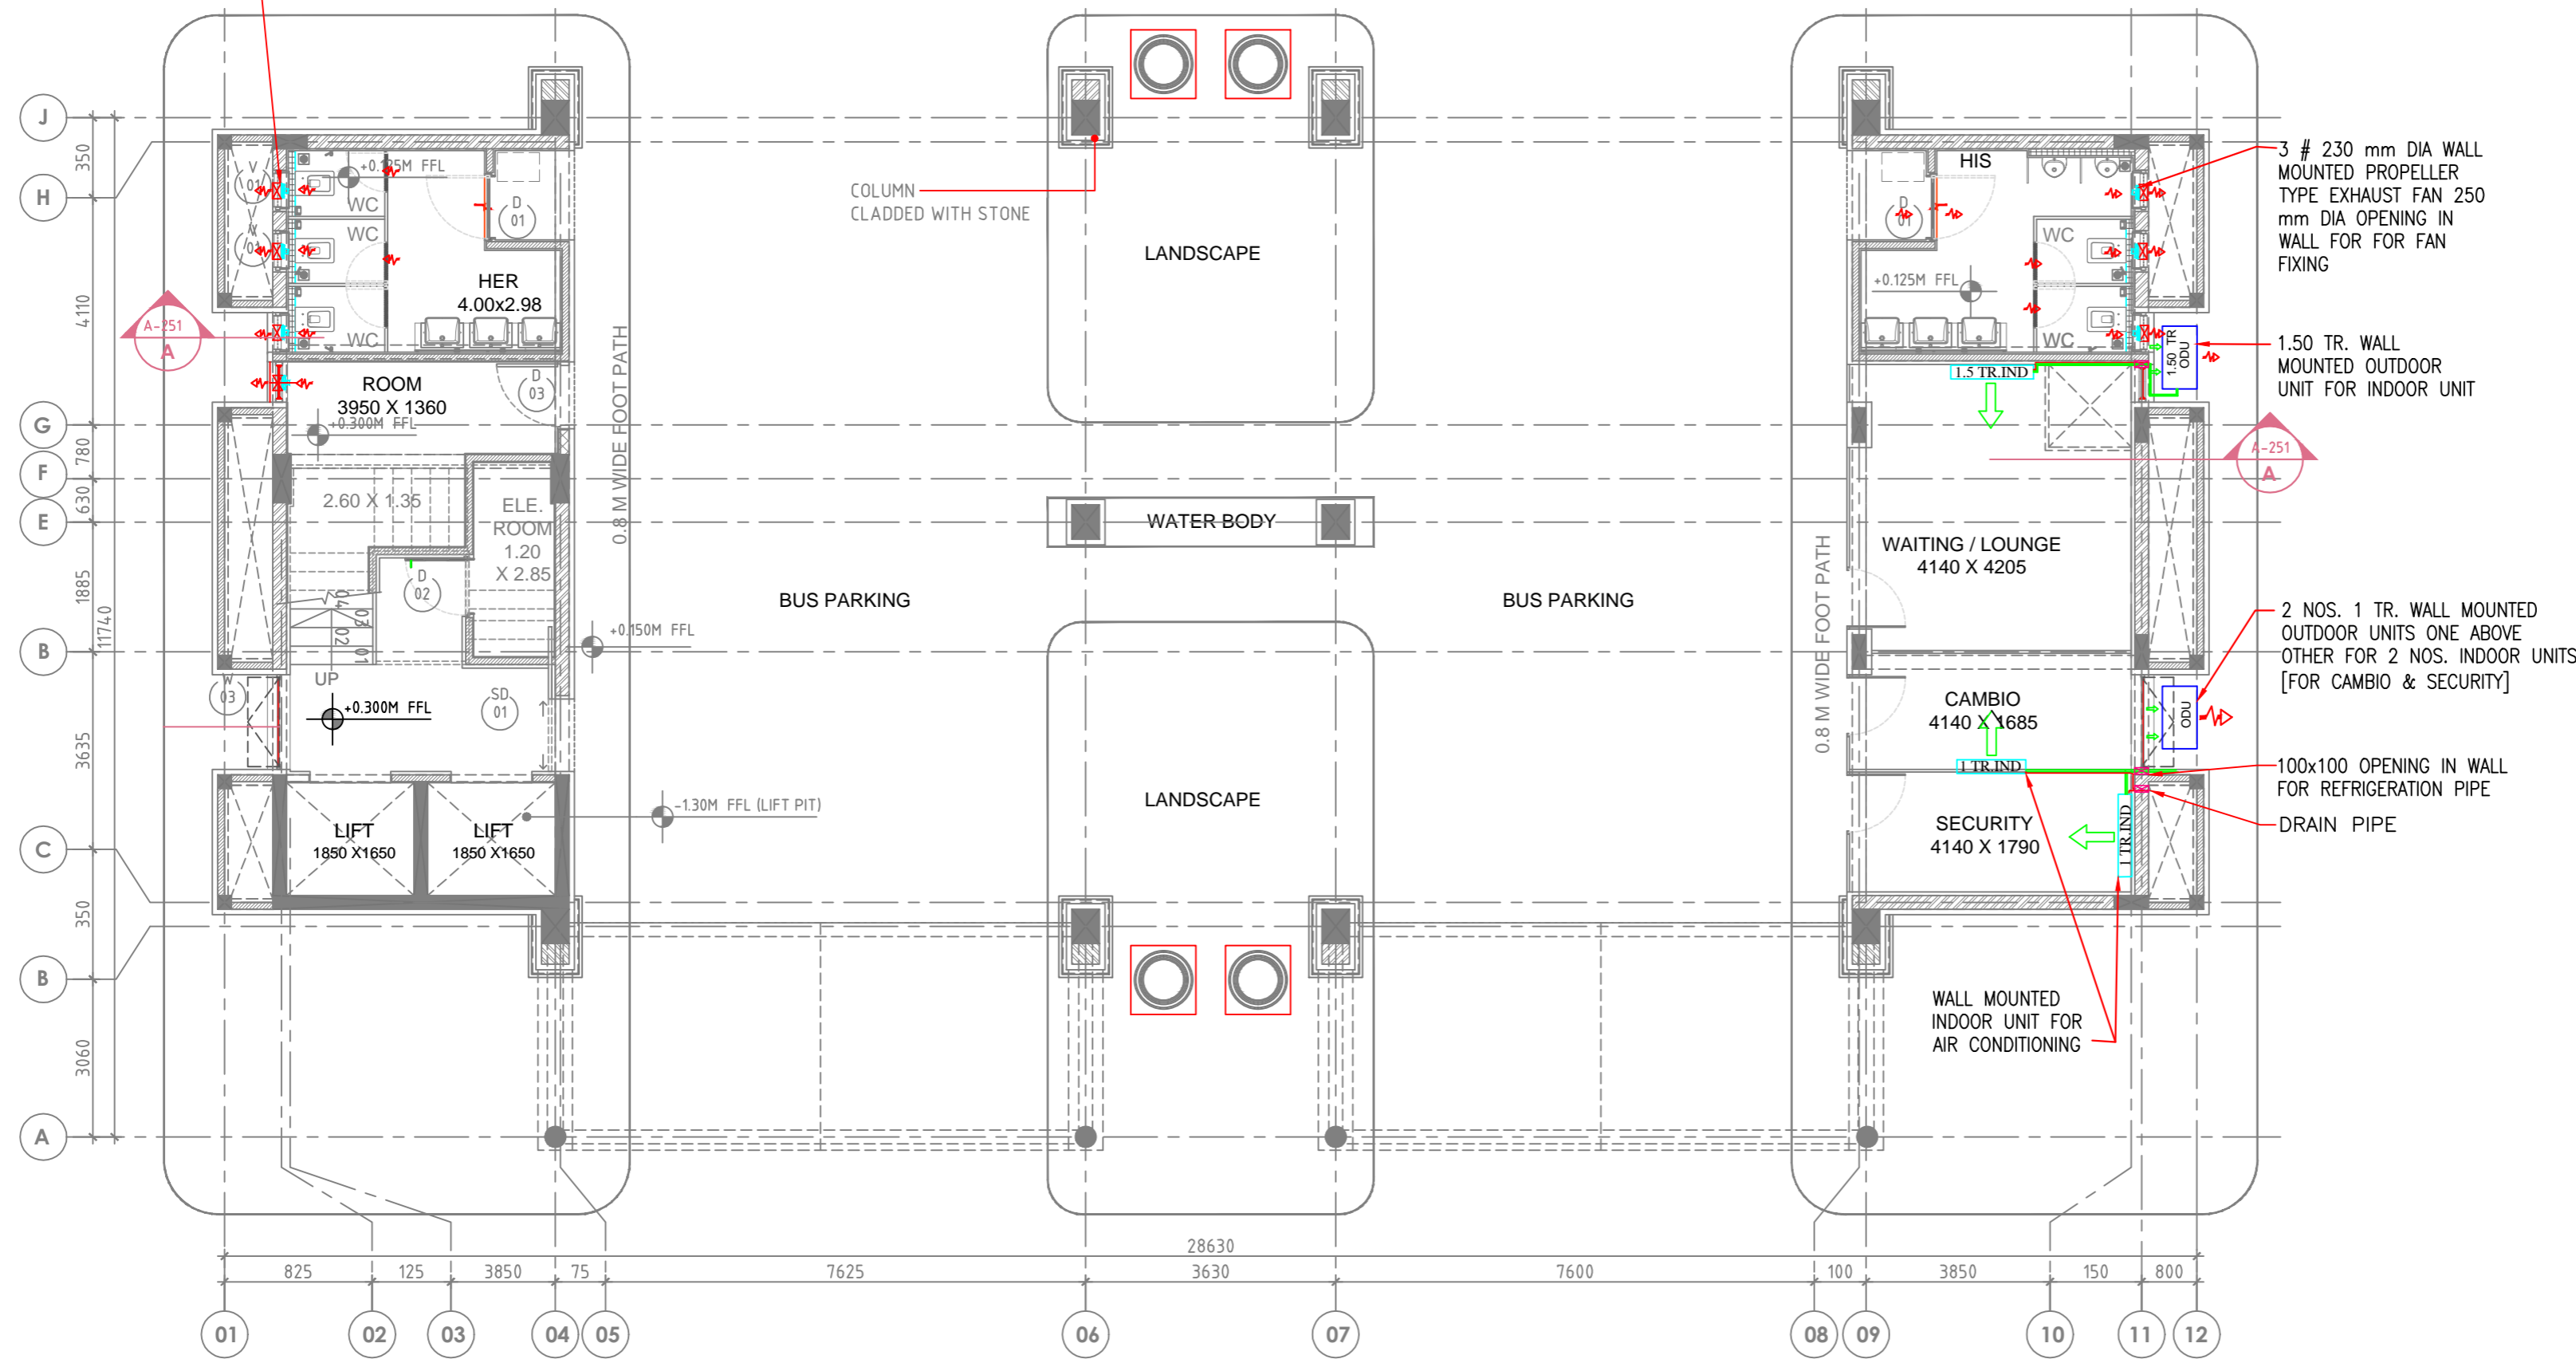

1 GROUND FLOOR PLAN
SCALE 1:125

NOTES :-

- ALL DIMENSIONS ARE IN MILLIMETER AND LEVELS IN METER UNLESS SPECIFIED OTHERWISE.
- DRAWING NOT TO BE SCALED WRITTEN DIMENSIONS TO BE FOLLOWED.
- THIS DRAWING SHALL BE READ IN CONJUNCTION WITH DRAWINGS OF RELEVANT DISCIPLINES.
- DISCREPANCY IF ANY SHALL BE BROUGHT TO THE NOTICE OF ARCHITECT / CONSULTANT.

LEGEND :-

REFERENCE DRG. NO.

1] THIS DRG. BASED ON REVISED ARCHITECTURAL DRG. NO. WTE-2185/02/101 REV. 2 GROUND FLOOR PLAN DATED , 15 / 04 / 2015 ,

HVAC TENDER DRG

6							
5							
4							
3							
2	17-08-2015	STB	JP		REVISED AS PER REQUIRE A.C. TR. AS PER CLIENT REQUIREMENT .		JP
1	16-04-2015	STB	SP		REVISED AS PER ARCH. DRG. NO 101 REV. 2 DT. 5-04-15		SP
0	05-12-14	STB	SP		NEW DRAWING		SP
Rev.	Date	Drawn	Code	Sign.	Description	Code	Sign.
			Checked			Approved	

File name :-
PLOT NO: PLOT AREA:
BUILT-UP AREA: FLOOR AREA:


 Client: **MORMUGAO PORT TRUST**
 Project: CRUISE TERMINAL BUILDING AT MORMUGAO HARBOUR, GOA

Title : HVAC LAYOUT - GROUND FLOOR PLAN

North	A3	WTE-2185	02	01	800	R2	1	1
	Scale	Job no.	Stage	Bldg.no.	Drg.no.	Rev.	Sheet	Of