


**NOTES :-**

- ALL DIMENSIONS ARE IN MILLIMETER AND LEVELS IN METER UNLESS SPECIFIED OTHERWISE.
- DRAWING NOT TO BE SCALED WRITTEN DIMENSIONS TO BE FOLLOWED.
- THIS DRAWING SHALL BE READ IN CONJUNCTION WITH DRAWINGS OF RELEVANT DISCIPLINES.
- DISCREPANCY IF ANY SHALL BE BROUGHT TO THE NOTICE OF ARCHITECT / CONSULTANT.

**LEGEND :-**

**REFERENCE DRG. NO.**

1 | THIS DRG. BASED ON REVISED ARCHITECTURAL DRG. NO. WTE-2185/02/105 REV. 2 TERRACE FLOOR PLAN DATED , 15 / 04 / 2015 ,

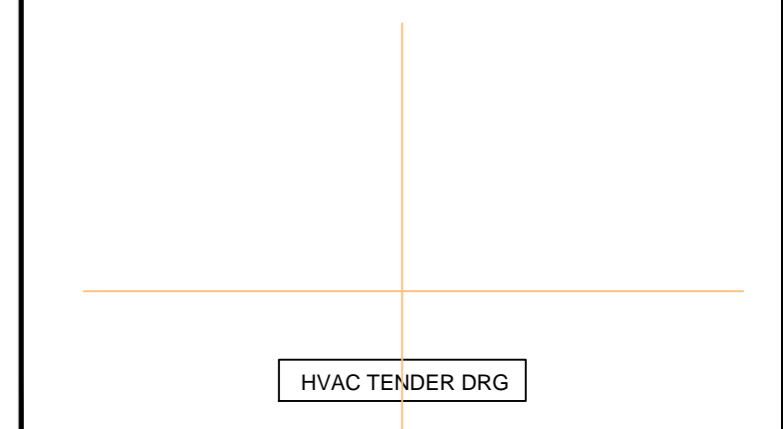

**1 TERRACE FLOOR PLAN**  
SCALE 1:125

6									
5									
4									
3									
2	17-08-2015	STB	JP		REVISED AS PER REQUIRE A.C. TR. AS PER CLIENT REQUIREMENT .			JP	
1	16-04-2015	STB	SP		REVISED AS PER ARCH. DRG. NO 101 REV. 2 DT. 5-04-15			SP	
0	05-12-14	STB	SP		NEW DRAWING			SP	
Rev.	Date	Drawn	Code	Sign.	Description	Code	Sign.	Checked	Approved

File name :-

PLOT NO: PLOT AREA:

BUILT-UP AREA: FLOOR AREA:

**Wadia Techno Engg. Services Ltd. Mumbai** Client **MORMUGAO PORT TRUST** Project **CRUISE TERMINAL BUILDING AT MORMUGAO HARBOUR, GOA**

Title : HVAC LAYOUT - TERRACE FLOOR PLAN

North	A3 1:100 Scale	WTE-2185 Job no.	02 Stage	01 Bldg.no	804 Drg.no.	R1 Rev.	1 Sheet	1 Of
-------	----------------------	---------------------	-------------	---------------	----------------	------------	------------	---------